


FORESHORE WALK PROJECT NAGAMBIE LAKE, NAGAMBIE CIVIL WORKS

Sheet List Table

SHEET NUMBER	SHEET TITLE
--	Face
1	Layout Plan (1)
2	Layout Plan (2)
3	Layout Plan (3)
4	Connection to existing jetty
5	Partnear Title Sheet
6	Partnear - Framing Details
7	Partnear - Framing Details
8	Partnear - Section & Details
9	Partnear - Section & Details

Reference No.
CR9770
REVISION 05

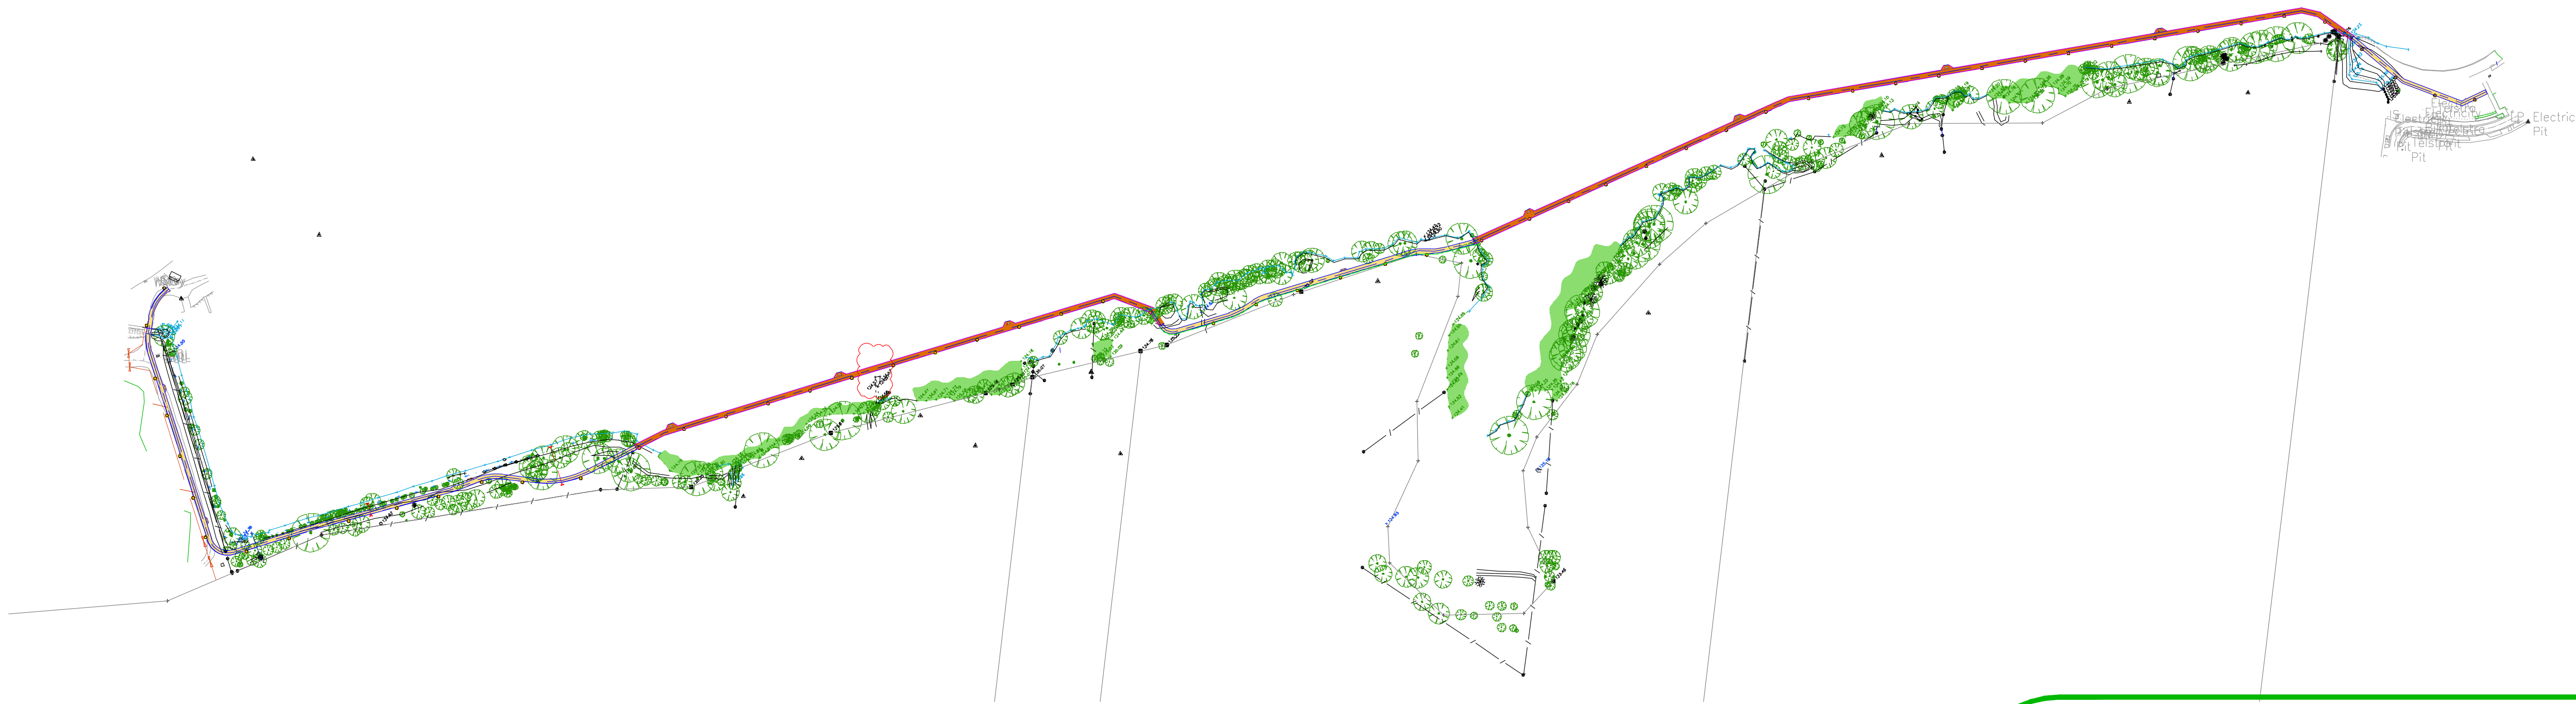

THESE PLANS HAVE
BEEN SUBMITTED TO
STRATHBOGIE SHIRE
FOR APPROVAL

SIGNED: _____
DATE: 05 May 2021


NOT TO BE USED FOR CONSTRUCTION UNTIL APPROVED.

IDEAS INTO ACTION

PLANRIGHT

Civil Engineers, Irrigation Designers, Licensed Surveyors.

139 Hogan Street, TATURA Ph. 03 58241322
21 Nish Street, ECHUCA Ph. 03 54821699
24B Sydney Street, KILMORE Ph. 03 57822238
Email: results@planright.com.au

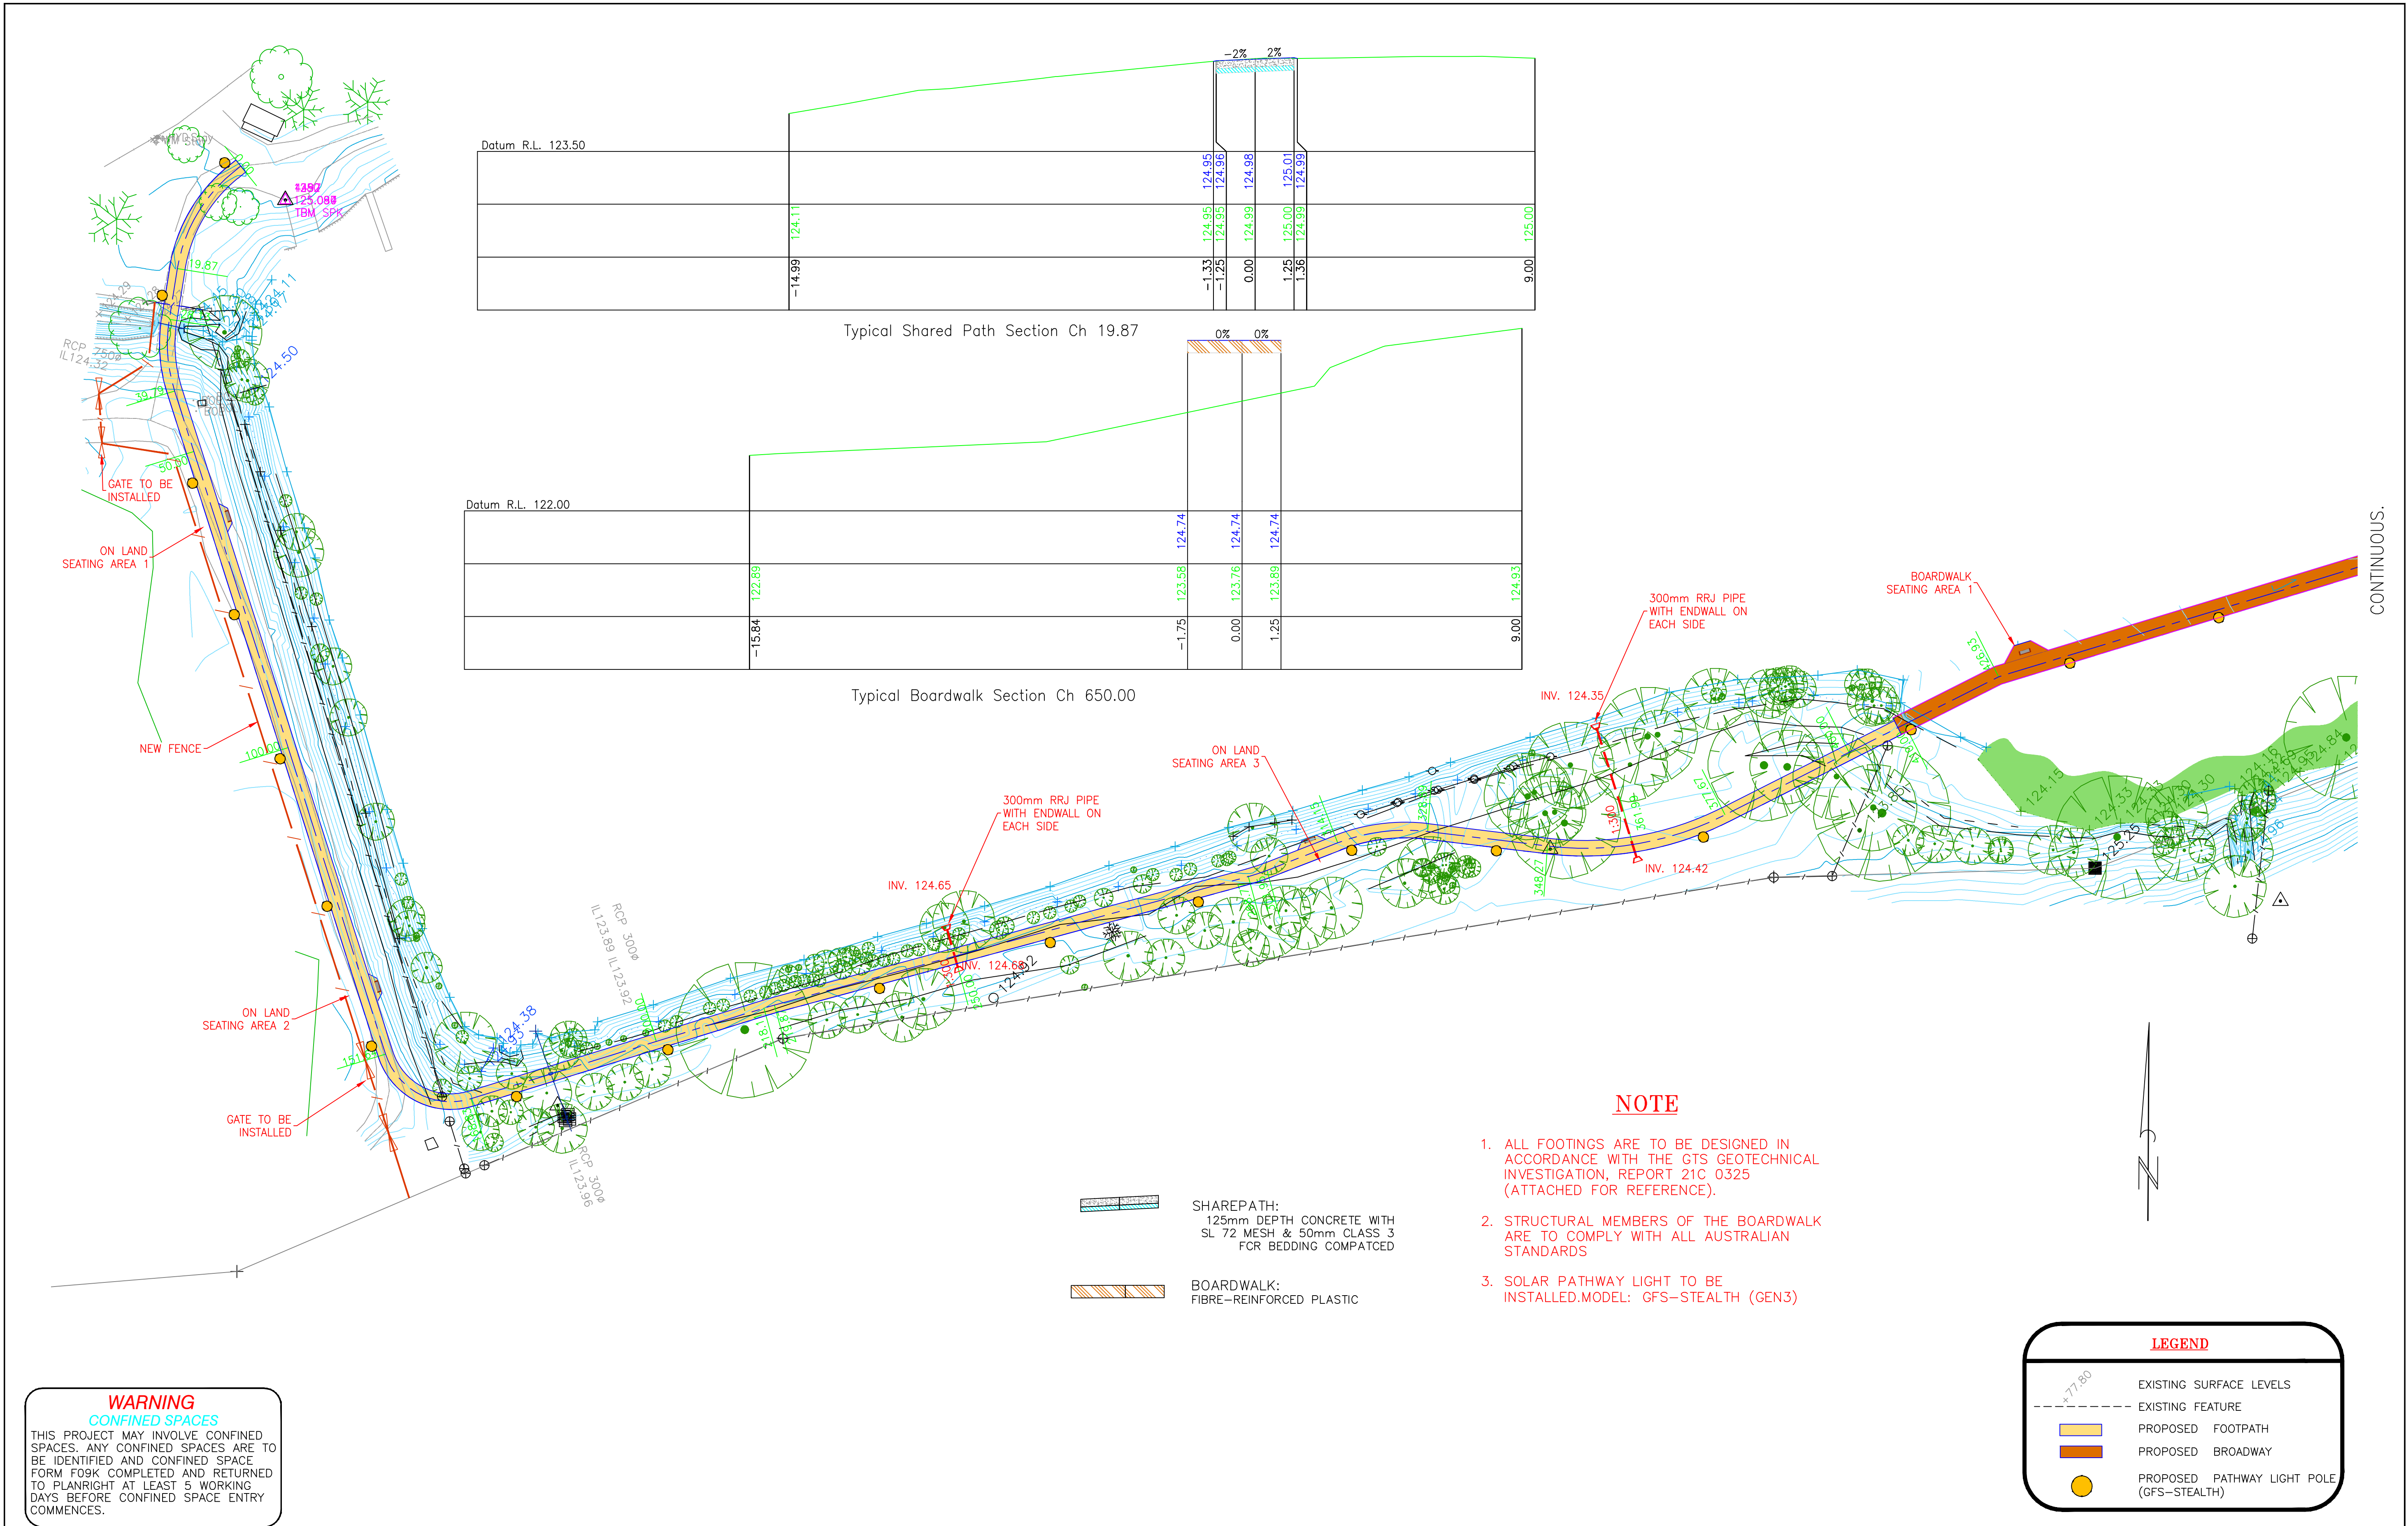

WARNING
CONFINED SPACES
THIS PROJECT MAY INVOLVE CONFINED SPACES. ANY CONFINED SPACES ARE TO BE IDENTIFIED AND CONFINED SPACE FORM F09K COMPLETED AND RETURNED TO PLANRIGHT AT LEAST 5 WORKING DAYS BEFORE CONFINED SPACE ENTRY COMMENCES.

DISCLAIMER
Notwithstanding any description contained in the Plans or Specification the Contractor shall be responsible for satisfying himself as to the nature and extent of the specified works and the physical and legal conditions under which the works will be carried out, including means of access, extent of clearing, nature of material to be excavated, type and size of mechanical plant required and any like matters effecting the construction of the works.

WARNING
BEWARE OF UNDERGROUND SERVICES
The location of underground services, where shown, are approximate only.
All authorities must be contacted prior to construction to determine the exact location of all underground services.

RELEASE	H	
	G	
	F	
	E	
	D	
	C	
	B	
	A	
No.	DATE	DESCRIPTION


SCALE:	
HOR: 1:500 (A1)	
0m 5 10 20 30 40	
VER: N/A	
DOCUMENT PURPOSE:	
☐ PRELIMINARY ONLY	☐ CONSTRUCTION
☐ APPROVAL	☐ AS CONSTRUCTED
☐ FOR TENDER ONLY	☐ OTHER

B.M. No.:	B.M.EI.:
DATUM: A.H.D.	
SURVEYED: Planright	Mar '21
DESIGNED: SH	Apr '21
DRAWN: SH	Apr '21
CHECKED: MMc	May '21
ORIGINAL SHEET SIZE : A1	

PLANRIGHT
Civil Engineers, Irrigation Designers, Licensed Surveyors.
139 Hogan Street, TATURA Ph. 03 58241322
24B Sydney St, KILMORE Ph. 03 57822238
21 Nish Street, ECHUCA Ph. 03 54821699
Email: results@planright.com.au

Client: Strathbogie Shire
NAGAMBIE LAKE
FORESHORE WALK PROJECT
CIVIL WORKS
Layout Plan (1)
CAD: CR9770 Nagambie Foreshore Walk Design
PLOTTED: 14/09/2021

DRAWING No.
CR9770/2
SHEET 2 OF 9
RELEASE 05

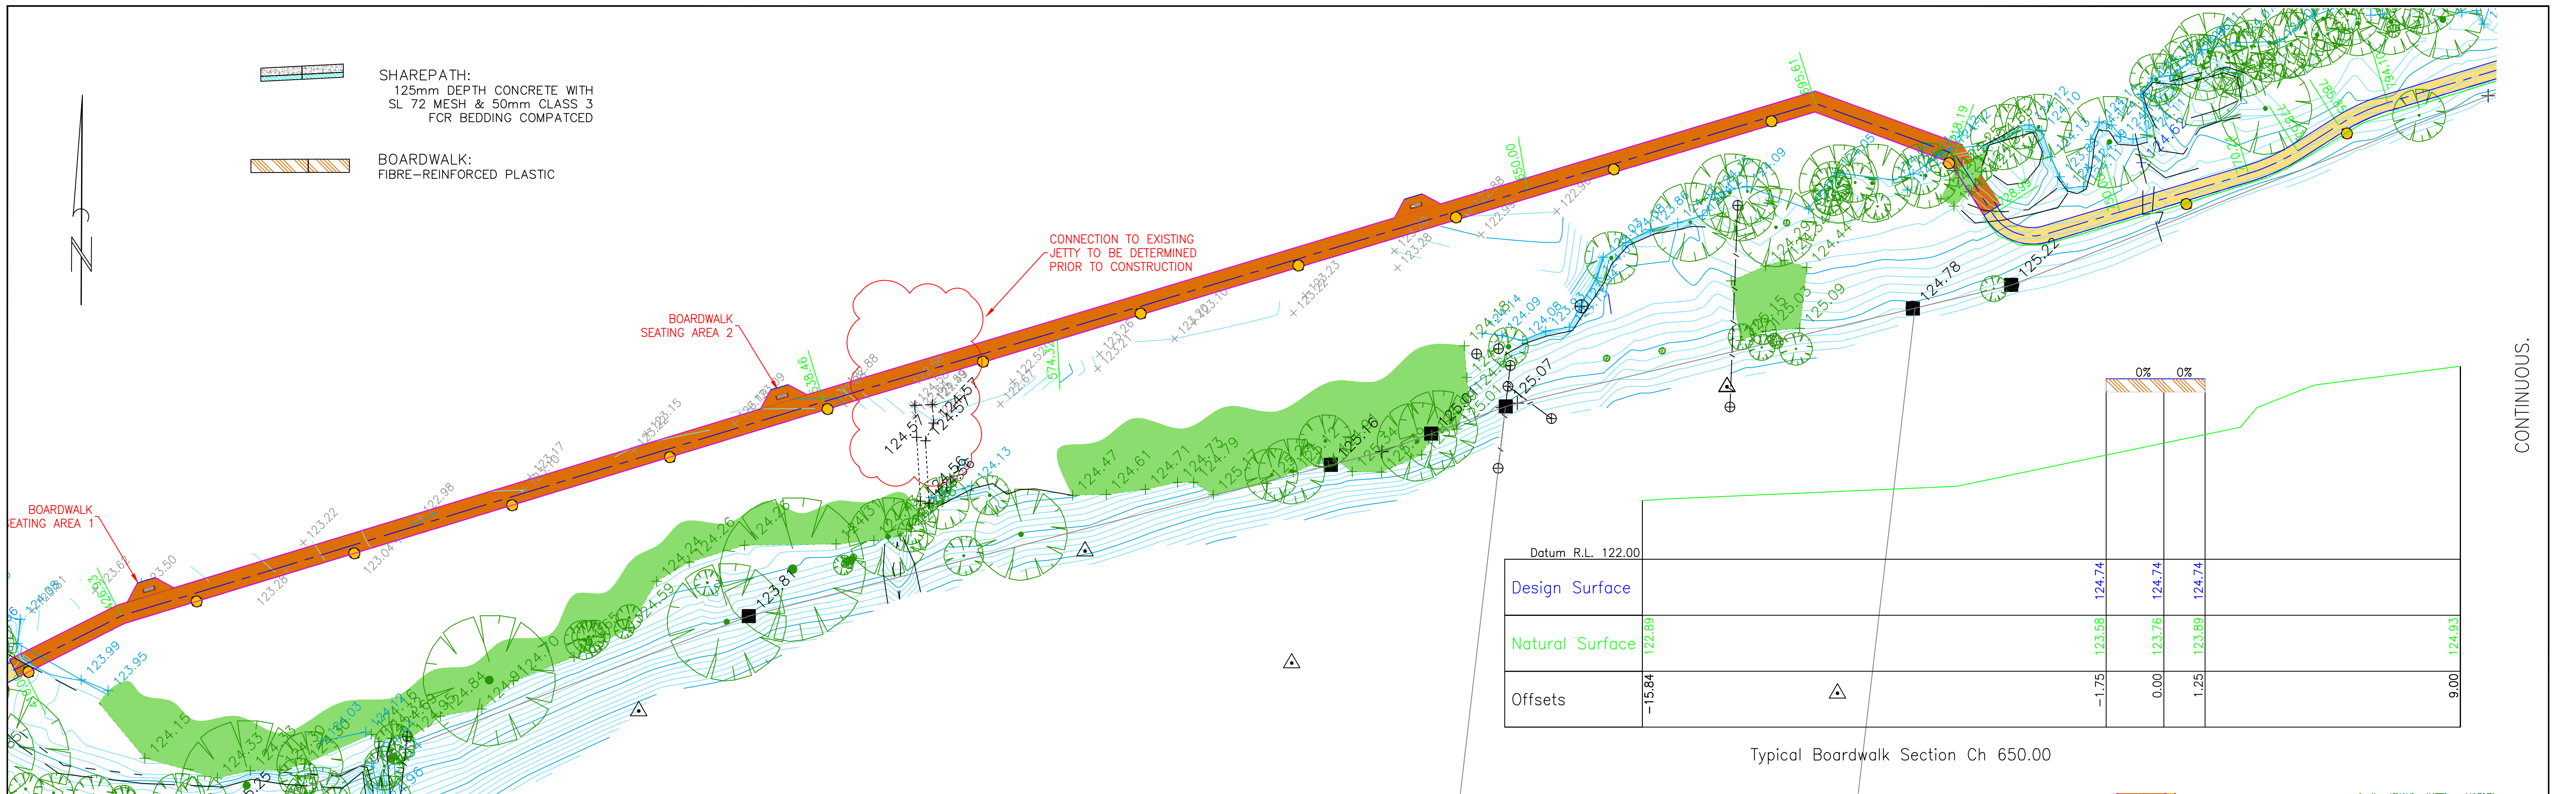


NOTE

1. ALL FOOTINGS ARE TO BE DESIGNED IN ACCORDANCE WITH THE GTS GEOTECHNICAL INVESTIGATION, REPORT 21C 0325 (ATTACHED FOR REFERENCE).
2. STRUCTURAL MEMBERS OF THE BOARDWALK ARE TO COMPLY WITH ALL AUSTRALIAN STANDARDS
3. SOLAR PATHWAY LIGHT TO BE INSTALLED.MODEL: GFS-STEALTH (GEN3)

**WARNING
CONFINED SPACES**

THIS PROJECT MAY INVOLVE CONFINED SPACES. ANY CONFINED SPACES ARE TO BE IDENTIFIED AND CONFINED SPACE FORM F09K COMPLETED AND RETURNED TO PLANRIGHT AT LEAST 5 WORKING DAYS BEFORE CONFINED SPACE ENTRY COMMENCES.

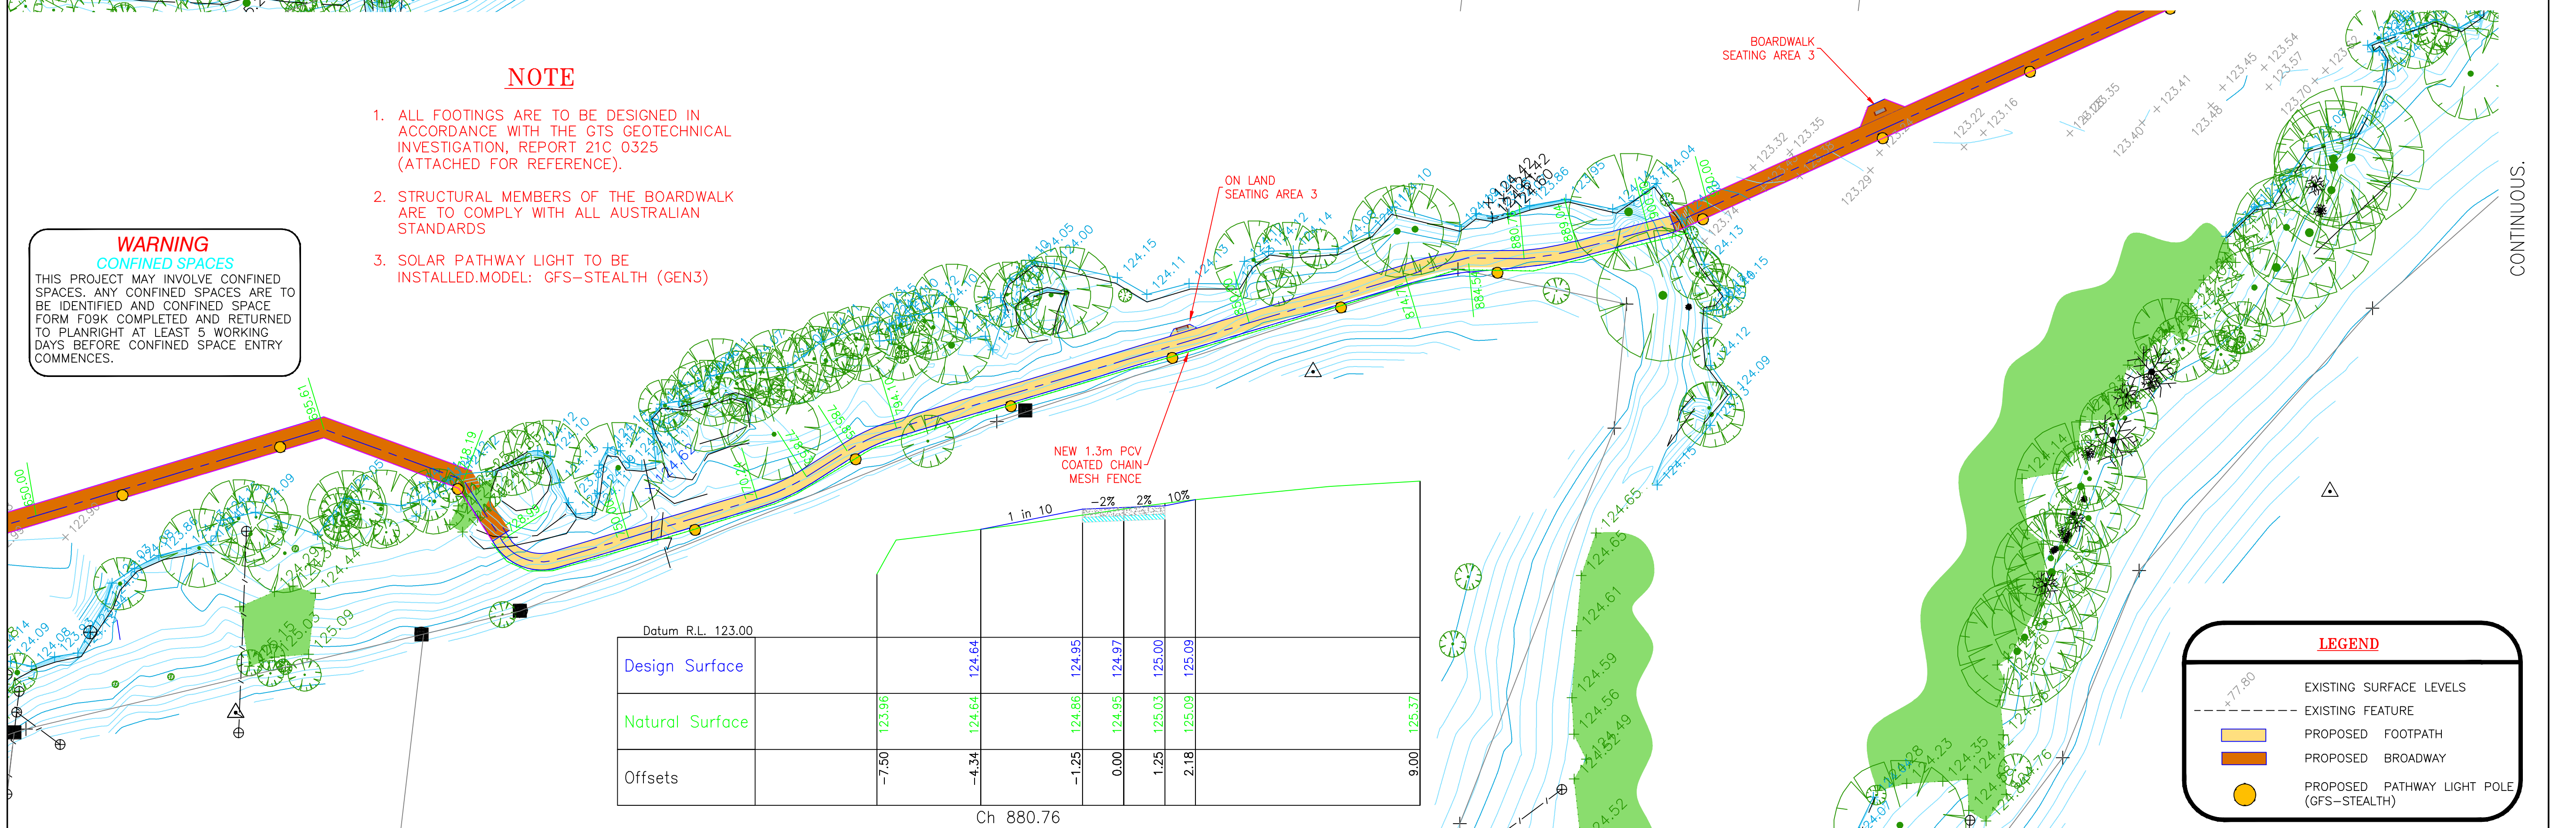

DISCLAIMER

Notwithstanding any description contained in the Plans or Specification the Contractor shall be responsible for satisfying himself as to the nature and extent of the specified works and the physical and legal conditions under which the works will be carried out, including means of access, extent of clearing, nature of material to be excavated, type and size of mechanical plant required and any like matters effecting the construction of the works.

INFORMATION CONTAINED ON THIS DRAWING IS THE COPYRIGHT OF PLANRIGHT AUSTRALASIA Pty. Ltd. COPYING OR USING THIS DRAWING IN WHOLE OR PART WITHOUT PERMISSION INFRINGES COPYRIGHT.

WARNING

BEWARE OF UNDERGROUND SERVICES

The location of underground services, where shown, are approximate only.

All authorities must be contacted prior to construction to determine the exact location of all underground services.

No.	DATE	DESCRIPTION

SCALE:	
HOR: 1:500 (A1)	
0m 5 10 20 30 40	
VER: N/A	
DOCUMENT PURPOSE:	
☐ PRELIMINARY ONLY	☐ CONSTRUCTION
☐ APPROVAL	☐ AS CONSTRUCTED
☐ FOR TENDER ONLY	☐ OTHER

B.M. No.:	B.M.El.:
DATUM: A.H.D.	
SURVEYED: Planright	Mar '21
DESIGNED: SH	Apr '21
DRAWN: SH	Apr '21
CHECKED: MMc	May '21
ORIGINAL SHEET SIZE : A1	

IDEAS INTO ACTION

PLANRIGHT

Civil Engineers, Irrigation Designers, Licensed Surveyors.

139 Hogan Street, TATURA Ph. 03 58241322
24B Sydney St, KILMORE Ph. 03 57822238
21 Nish Street, ECHUCA Ph. 03 54821699

Email: results@planright.com.au

Client: Strathbogie Shire

**NAGAMBIE LAKE
FORESHORE WALK PROJECT
CIVIL WORKS**

Layout Plan (2)

CAD: CR9770 Nagambie Foreshore Walk Design PLOTTED: 14/09/2021

DRAWING No. CR9770/3 RELEASE 05 SHEET 3 OF 9

